



PROPOSED NORTH ELEVATION
SCALE: 3/16"=1'-0"

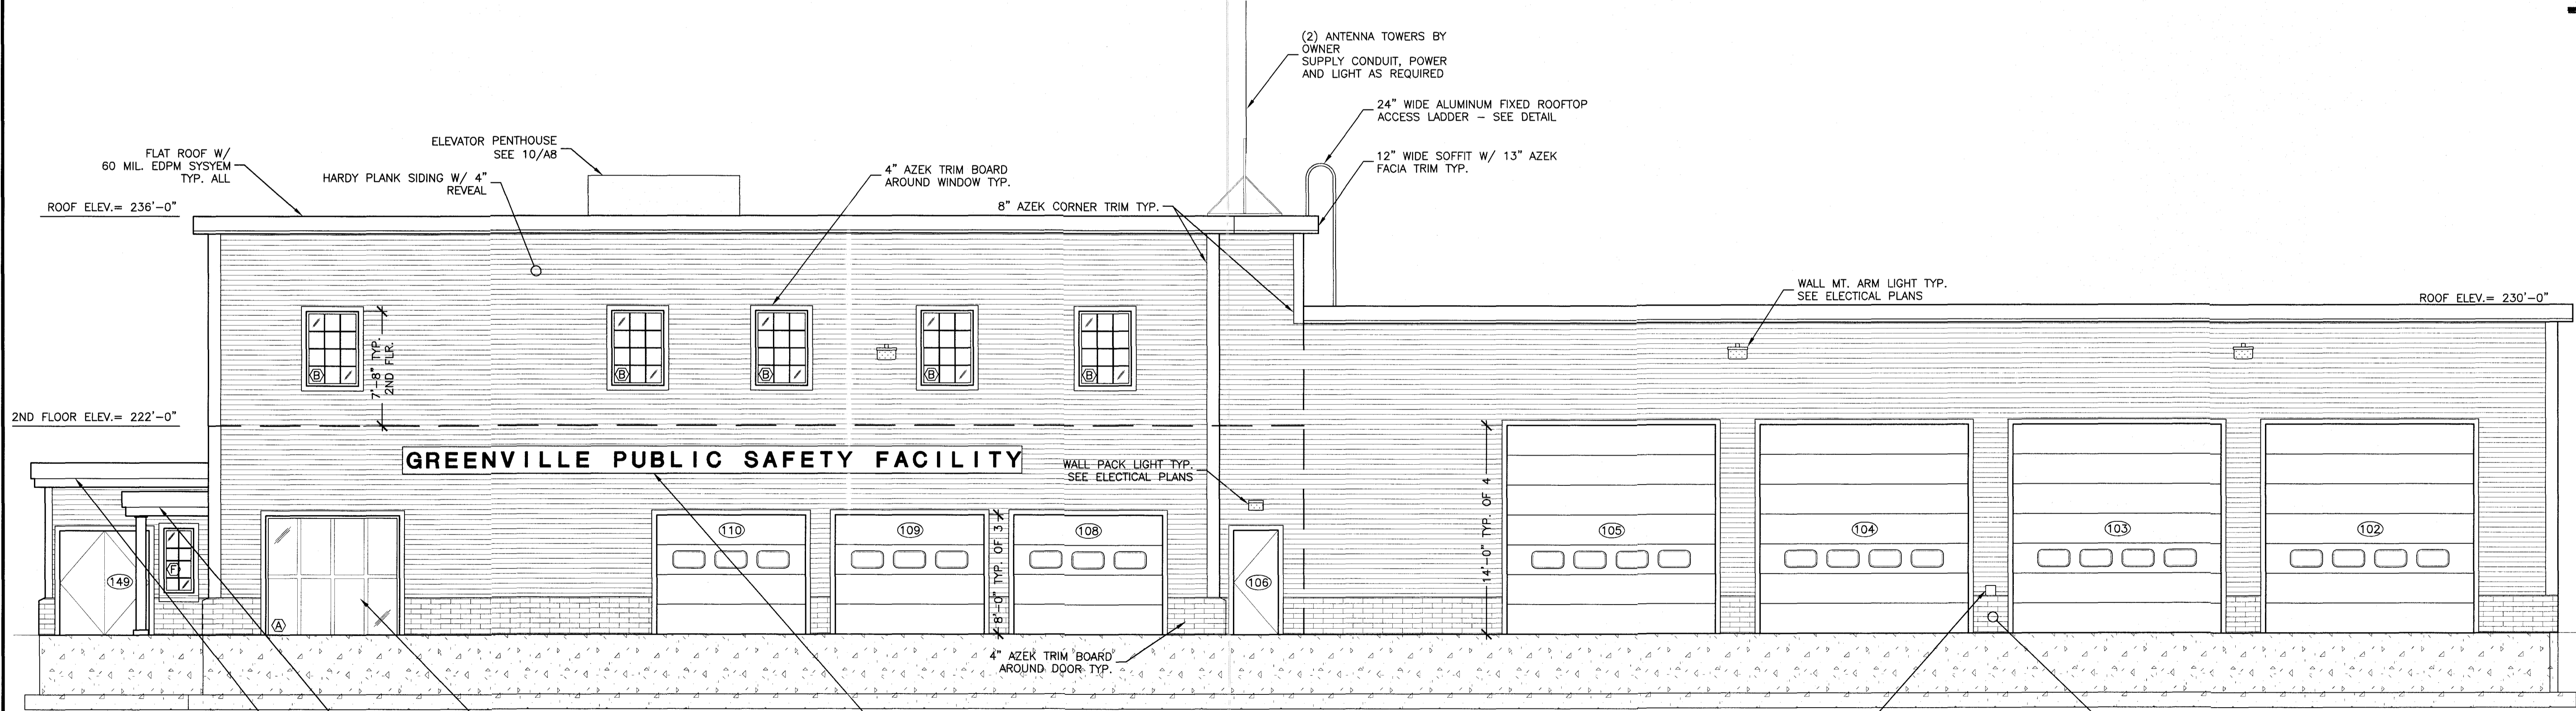

PROPOSED WEST ELEVATION
SCALE: 3/16"=1'-0"

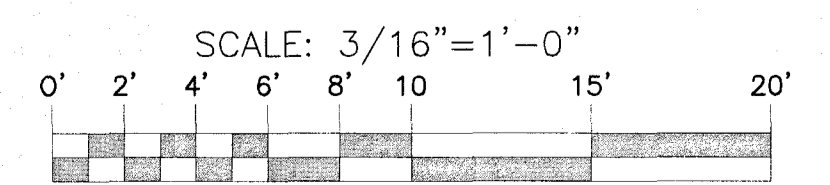

NO.	DATE	DESCRIPTION	DRAWN / APPD.

PROJECT NAME:
GREENVILLE PUBLIC SAFETY FACILITY
GREENVILLE MAINE
SHEET NAME:
NORTH & WEST ELEVATIONS

DESIGNED: SEB
DRAWN: SEB / KGE
CHECKED: SEB / KGE
APPROVED: SEB / KGE
PLAN DATE: MAR. 21, 2022
CLIENT: Town of Greenville
7 Minden St.
Greenville, Maine 04441

PROJECT NO. 21207
DRAWING NO. 21207A
FIELDBOOK: N/A
SCALE: AS SHOWN
DATE ISSUED: AS SHOWN




Plymouth Engineering, Inc.
P.O. Box 46 30 Lower Detroit Road
Plymouth, Maine 04889
Tel: (207) 257-2071 Fax: (207) 257-2030
info@plymouthengineering.com
www.plymouthengineering.com

DRAWINGS NOT SEALED ARE FOR PLANNING PURPOSES ONLY AND ARE NOT INTENDED FOR PERMITTING, BIDDING OR CONSTRUCTION


Sheet 14 Of 72

A4


Mar 21, 2022 - 11:59am
J:\2021\21207 - Greenville fire department - Greenville - town\J. Drawings\BUILDING\Elevations.dwg

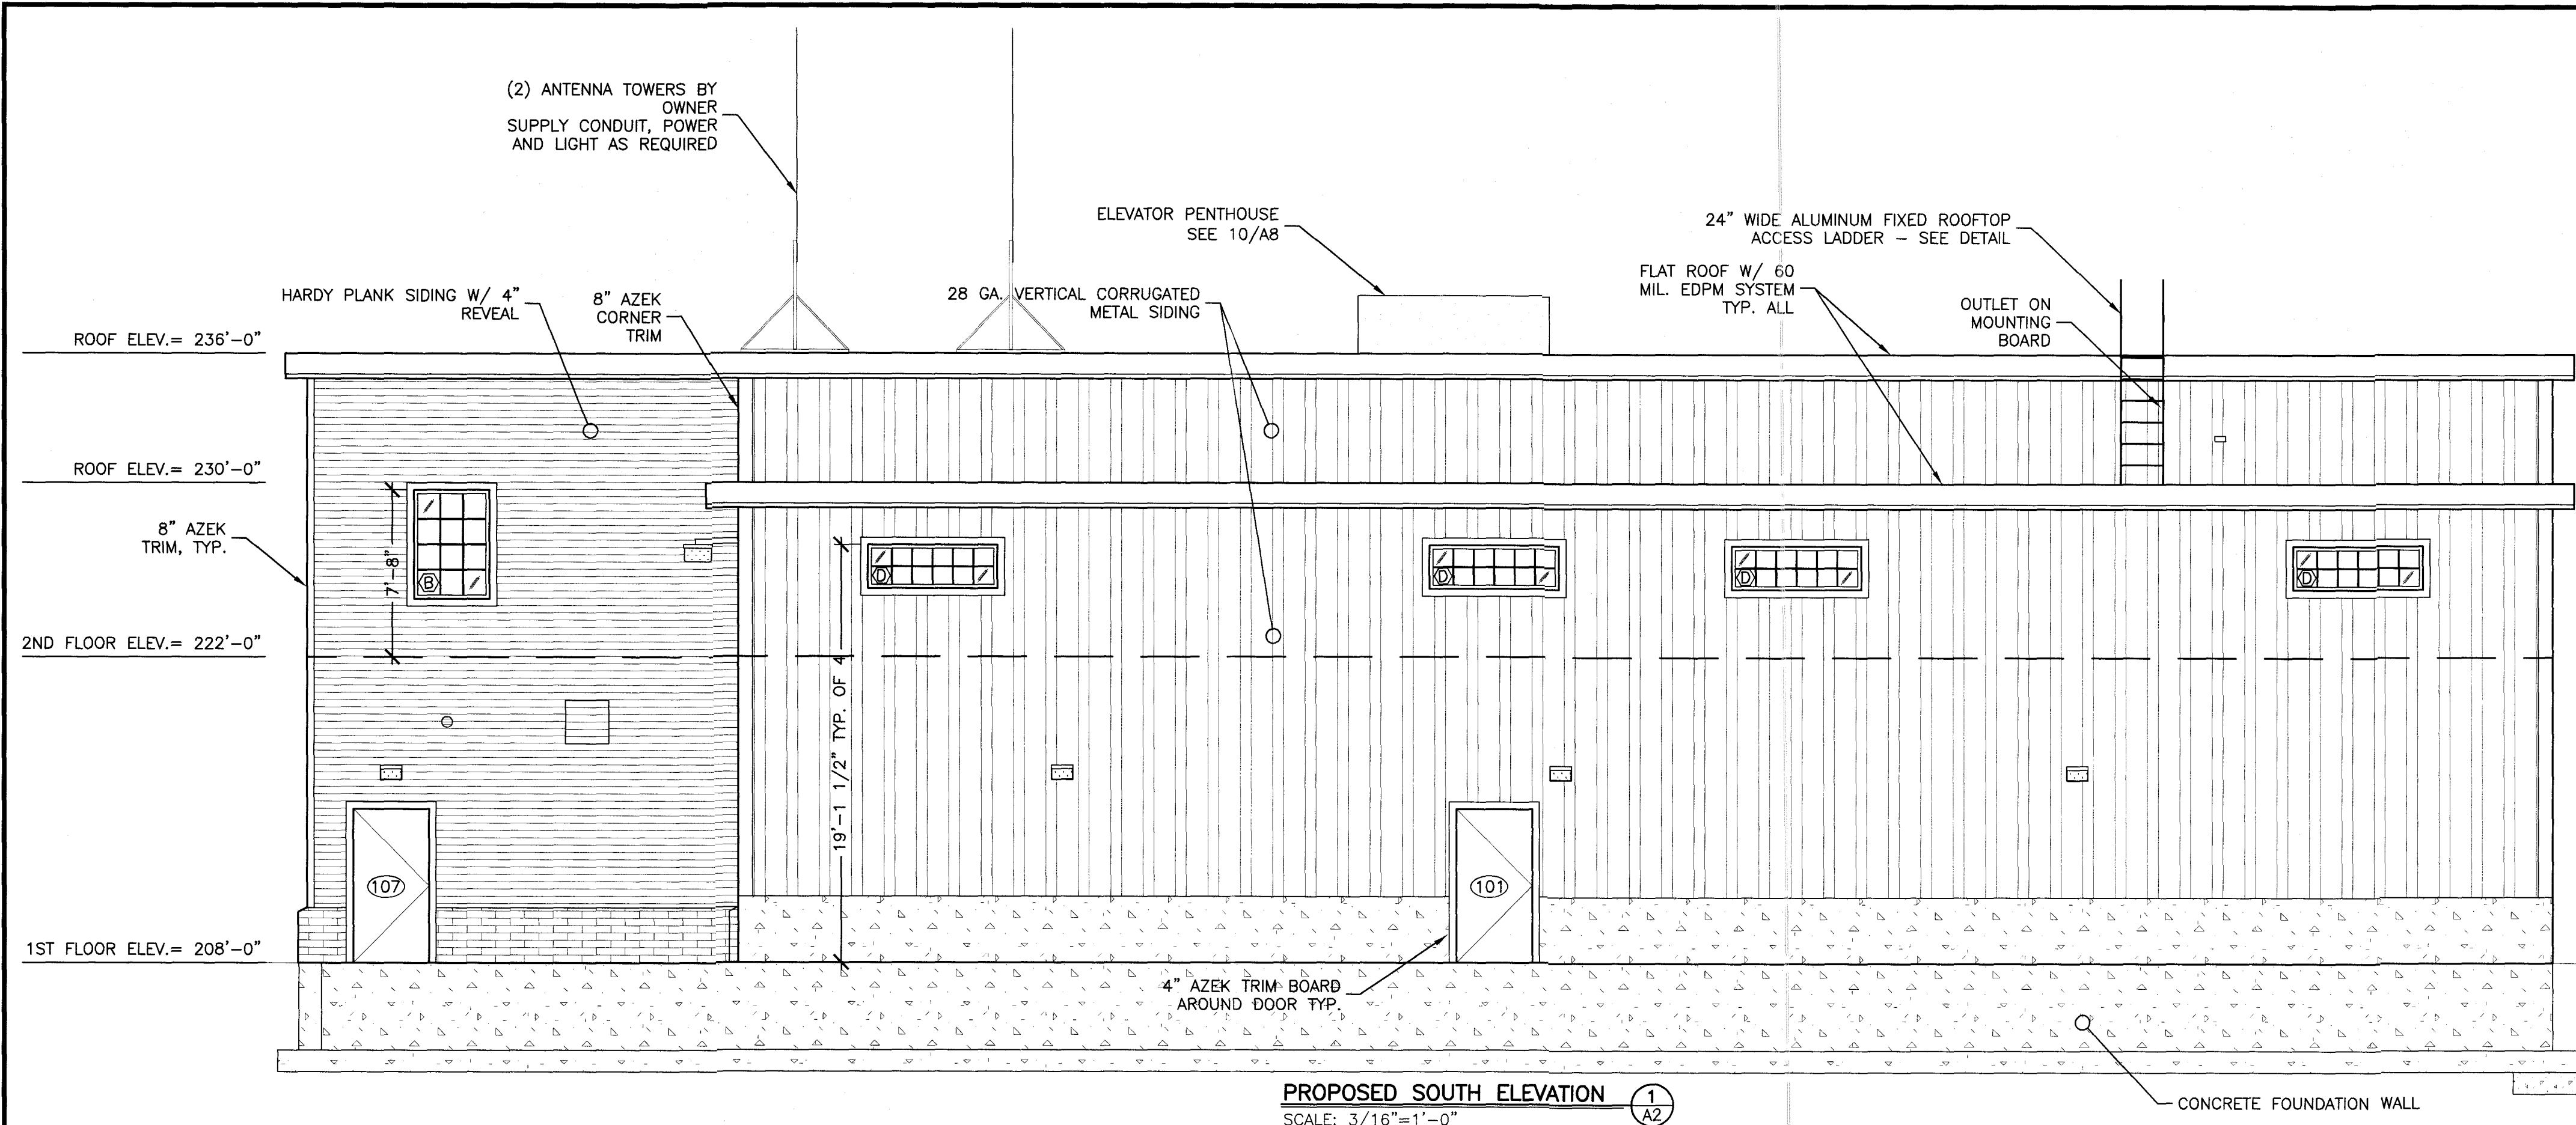

PROPOSED SOUTH ELEVATION
SCALE: 3/16"=1'-0" (1 A2)

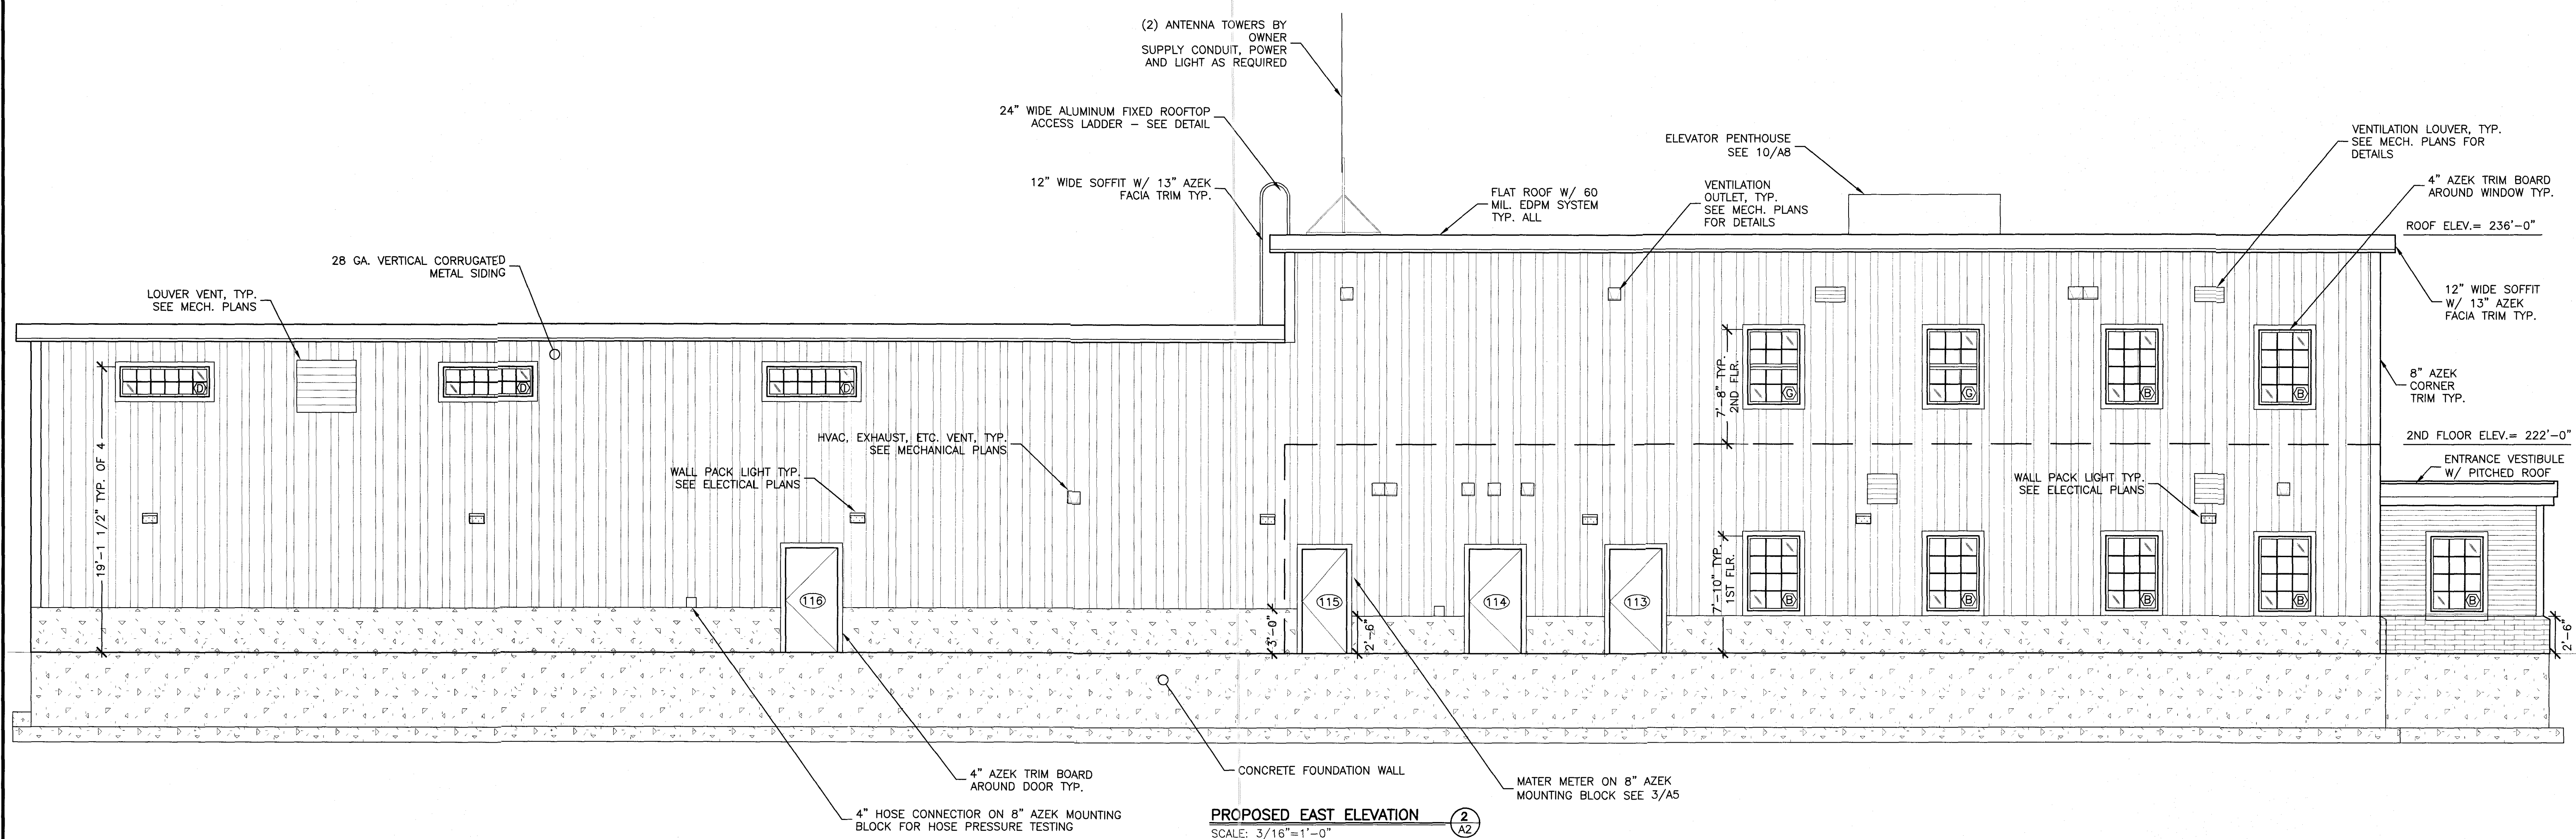

PROPOSED EAST ELEVATION
SCALE: 3/16"=1'-0" (2 A2)

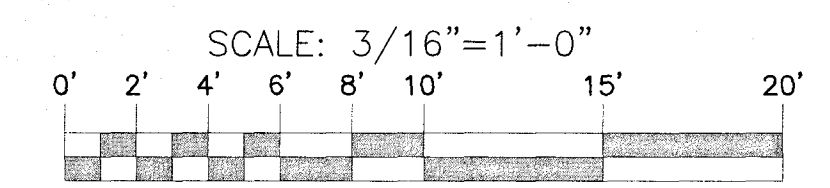


NO.	DATE	DESCRIPTION	DRAWN	APPD.

PROJECT NAME:
GREENVILLE PUBLIC SAFETY FACILITY
SHEET NAME:
SOUTH & EAST ELEVATION

DESIGNED: SEB
DRAWN: SEB / KGE
CHECKED: SEB / KGE
APPROVED: SEB / KGE
PLAN DATE: MAR. 21, 2022
DATE ISSUED:
CLIENT: Town of Greenville
7 Minden St.
Greenville, Maine 04441

Plymouth Engineering, Inc.
P.O. Box 48 30 Lower Detroit Road
Plymouth, Maine 04969
Tel: (207) 257-2071 Fax: (207) 257-2190
info@plymouthengineering.com
www.plymouthengineering.com

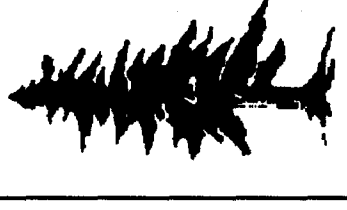

DRAWINGS NOT SEALED ARE FOR PLANNING PURPOSES ONLY AND ARE NOT INTENDED FOR PERMITTING, BIDDING OR CONSTRUCTION
Sheet 15 Of 72

A3

Mar 21, 2022 - 12:00pm
2/2022/2/2027 - Greenville fire department - greenville - town.town.L Drawings\BUIL\DNGL\Elevations.dwg