


PROPOSED FLOOR PLAN 1  
SCALE: 3/16" = 1'-0"

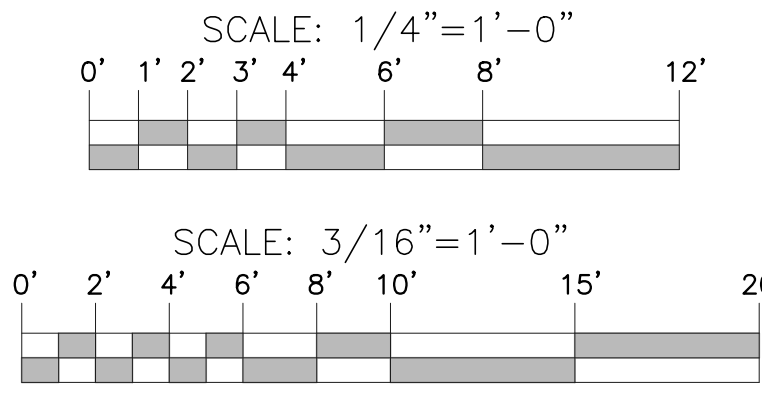

NO.	DATE	REVISIONS DESCRIPTION

PROJECT NAME: GREENVILLE FIRE STATION  
 PROJECT NO.: 21207  
 DRAWING NO.: 21207A  
 GREENVILLE MAINE  
 FIRST FLOOR PLAN

DESIGNED: KGE  
 DRAWN: LUF  
 CHECKED: KGE  
 APPROVED: KGE  
 PLAN DATE: 3/9/2022  
 CLIENT & OWNER: MIKE ROY 108 BOX ROAD GREENVILLE, MAINE 04441

**Plymouth Engineering, Inc.**  
 8 Main Street, Unit C  
 Newport, Maine 04953  
 Tel: (207) 257-2071 Fax: (207) 257-2130  
 info@plymouthengineering.com  
 www.plymouthengineering.com

**PRELIMINARY**  
 DRAWINGS NOT SEALED ARE FOR PLANNING PURPOSES ONLY AND ARE NOT INTENDED FOR PERMITTING, BIDDING OR CONSTRUCTION